


**1 Plan View**  
1 : 30

Multi-Category Schedule		
Family and Type	QTY	Sym bol
DR_InternalDoor: 610x1981mm With Lock	3	
EF_ApplianceInletWallReces sed_SocketAndIsolator: With Isolator	1	
EF_DoubleSocket_SurfaceM ounted: EF_DoubleSocket_SurfaceM ounted	2	
EF_Generic_HeaterController _Wireless: Type 1	3	
EF_Generic_PullSwitch: Type 1	6	
EL_Downflow_Heater_2kW: Standard	3	
EL_ExtractFan: Extractor Fan 4 inch	3	
EL_Generic_ConsumerUnitS urfaceMounted_16Way: CONSUMER UNIT METAL CLAD 16WAY	1	
FU_ChangingBenchWithWall MountedHooks: Type 1	8	
LI_MelanaLED_BulkheadLig ht_300mmDia: LI_MelanaLED_BulkheadLig ht_300mmDia	13	
PE_Shower_WallBased: 760 x 760 7.5Kw ElectricShowerWithPlinth	5	
PE_StandardToilet_WallBase d: Type 1	3	
PF_HandBasinandHandWas hAssembly: With 3Kw Handwash	3	
UPVC High Level Window Guard: 710x410mm	7	

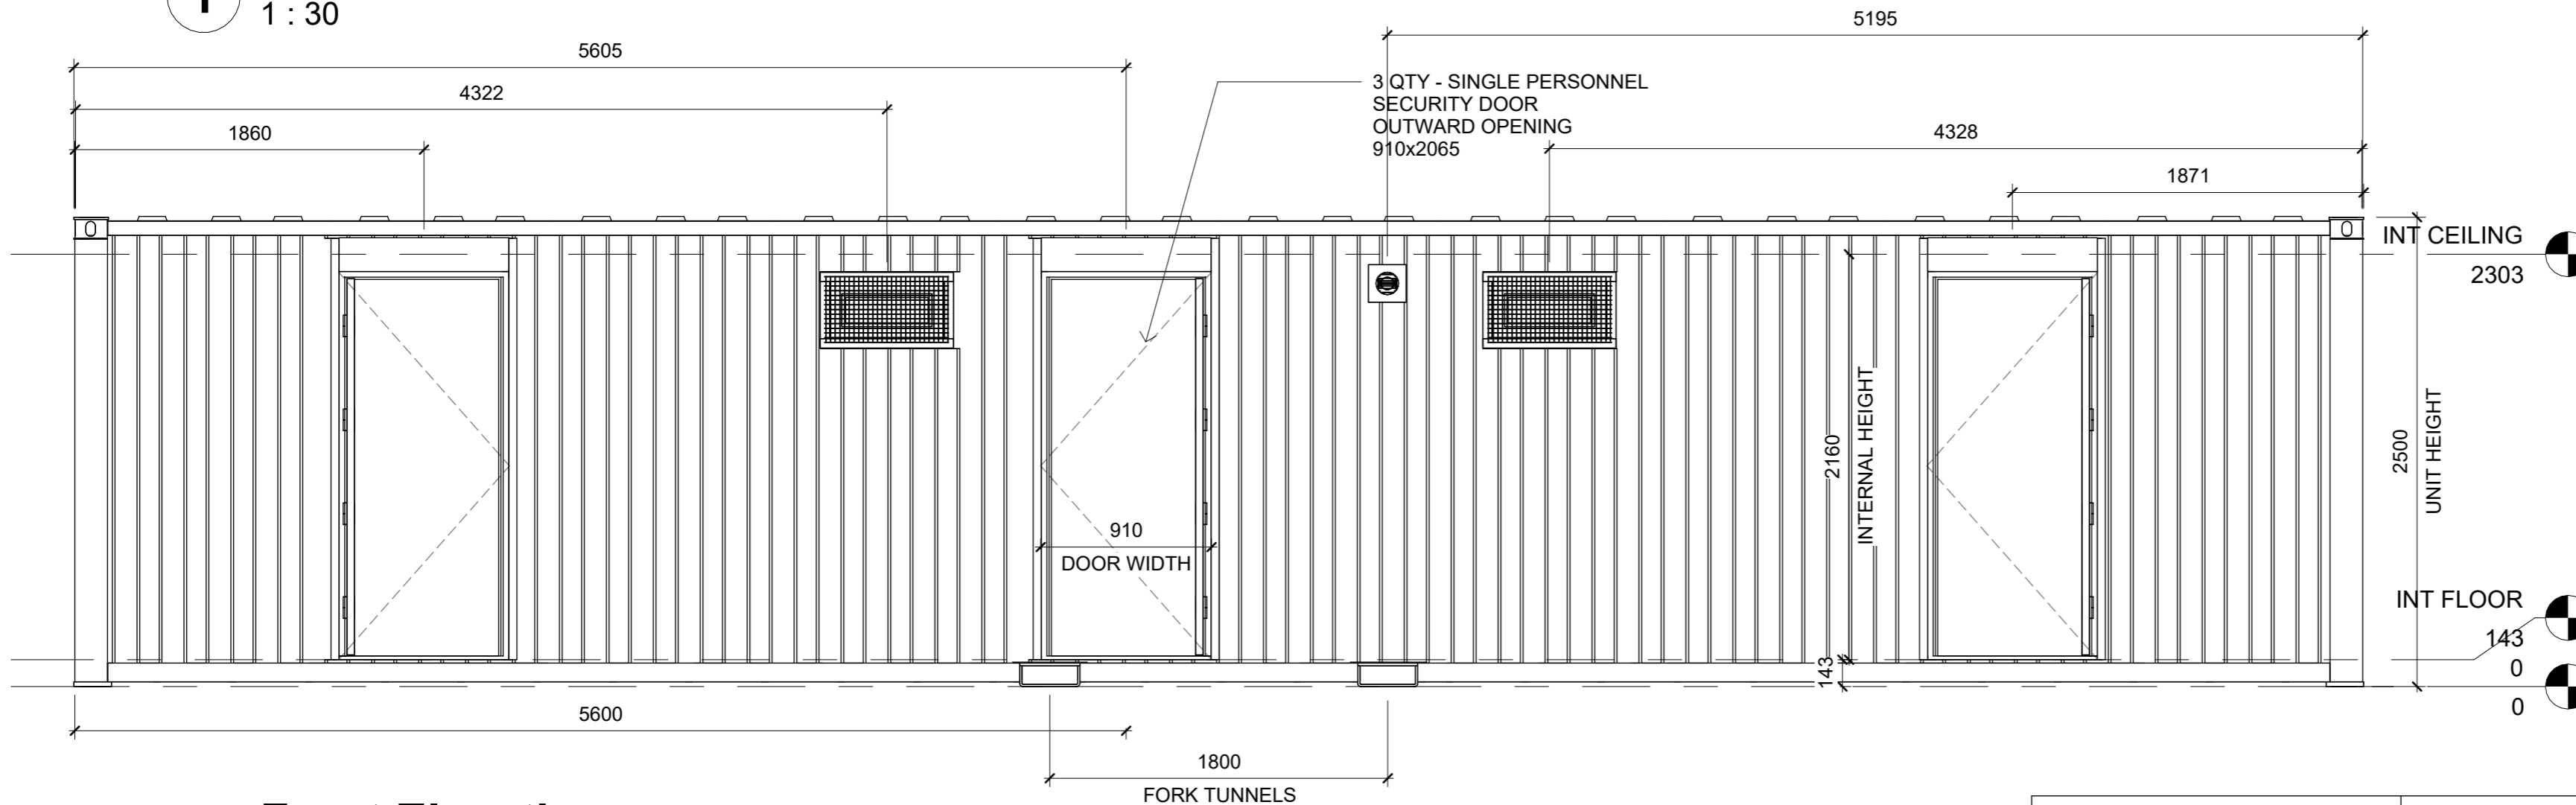


**3 Front Elevation**  
1 : 30

**LINING DETAILS:**  
**WALLS**  
 FLAT WHITE FACED VINYL PLY BOARD & 50MM INSULATION  
 SHOWER AREA: WHITE GEO PANELS  
**CEILING**  
 FLAT WHITE VINYL PLY BOARD & 25MM SPRAY FOAM + 50MM INSULATION  
**TRIMS**  
 WHITE PLASTIC  
**FLOOR**  
 POLYFLOR NON SLIP VINYL FLOORING OVER 15MM P5 TIMBER.


**40'x10' UNIT PROFILED WALLS**  
 BOTTOM RAIL SIZE: 100x50x10.42Kg/m P.F.C  
 TOP RAIL SIZE: 76x38x6.7Kg/m P.F.C  
 FLAT FACES OF TOP RAILS OUTWARD.  
 BEARER SIZE: 100x50x3mm R.H.S. @ 405mm CTRS.  
 ROOF RIBS: 3 Off 40x40x3mm S.H.S  
 WHITE UPVC FRAMED, DOUBLE GLAZED, HIGH LEVEL, FOV WINDOWS c/w OBSCURE GLASS & STEEL, MESH GUARDS.




CLIENT: Mac Containers	
PROJECT NO: NS00014-MAC-TO-4010	
DRAWING NAME: Overall Layout	
DRAWING NUMBER: 01	
REV: B	REV DATE: 06/07/23
REV DESCRIPTION: VOID ADDED FOR PIPEWORK	
DRAWN BY: MB	CHECKED BY: JH
DRAWING STATUS: FOR PRODUCTION	
SCALE:	1 : 30

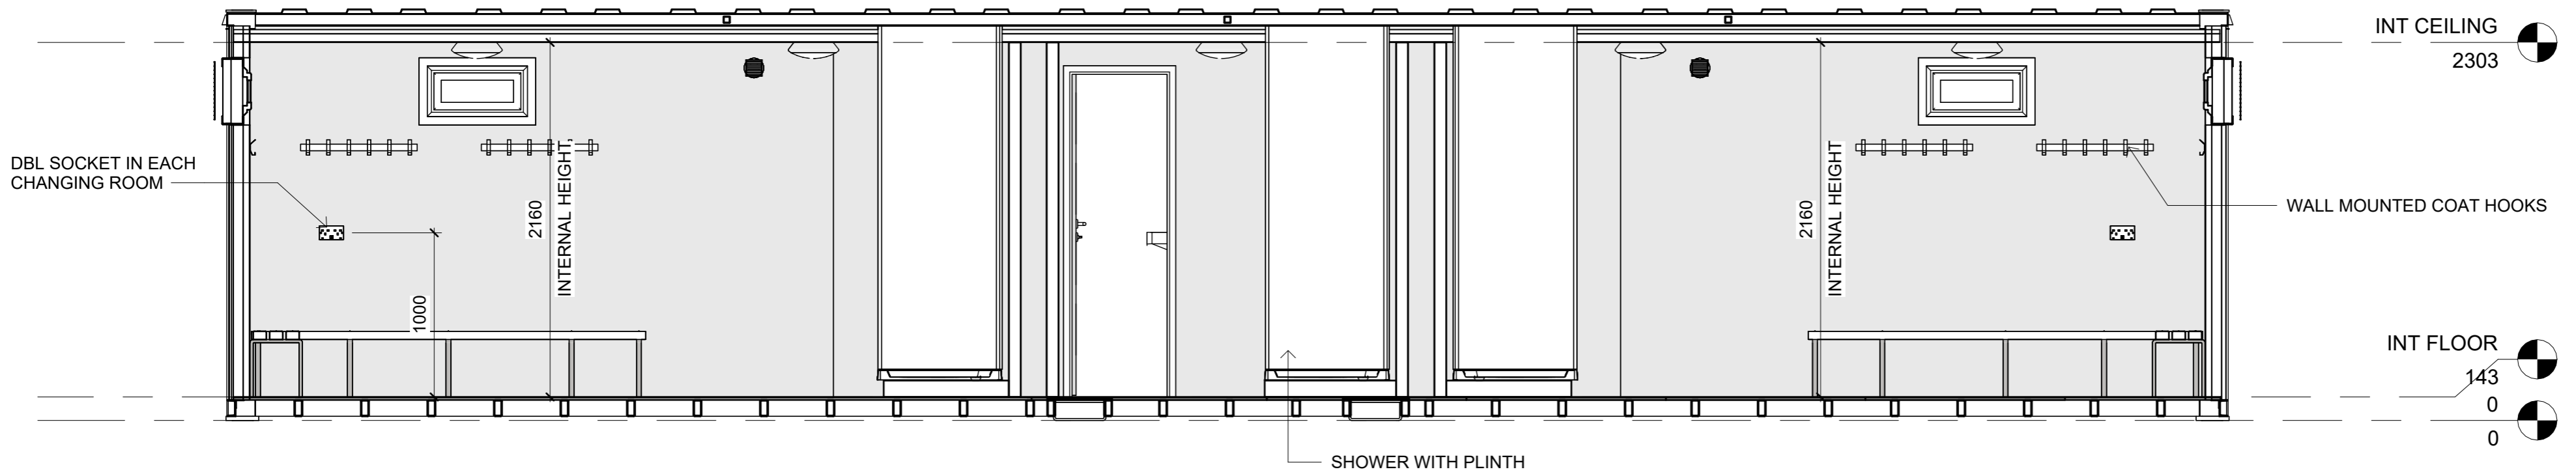


**1 Long Section**  
1 : 30

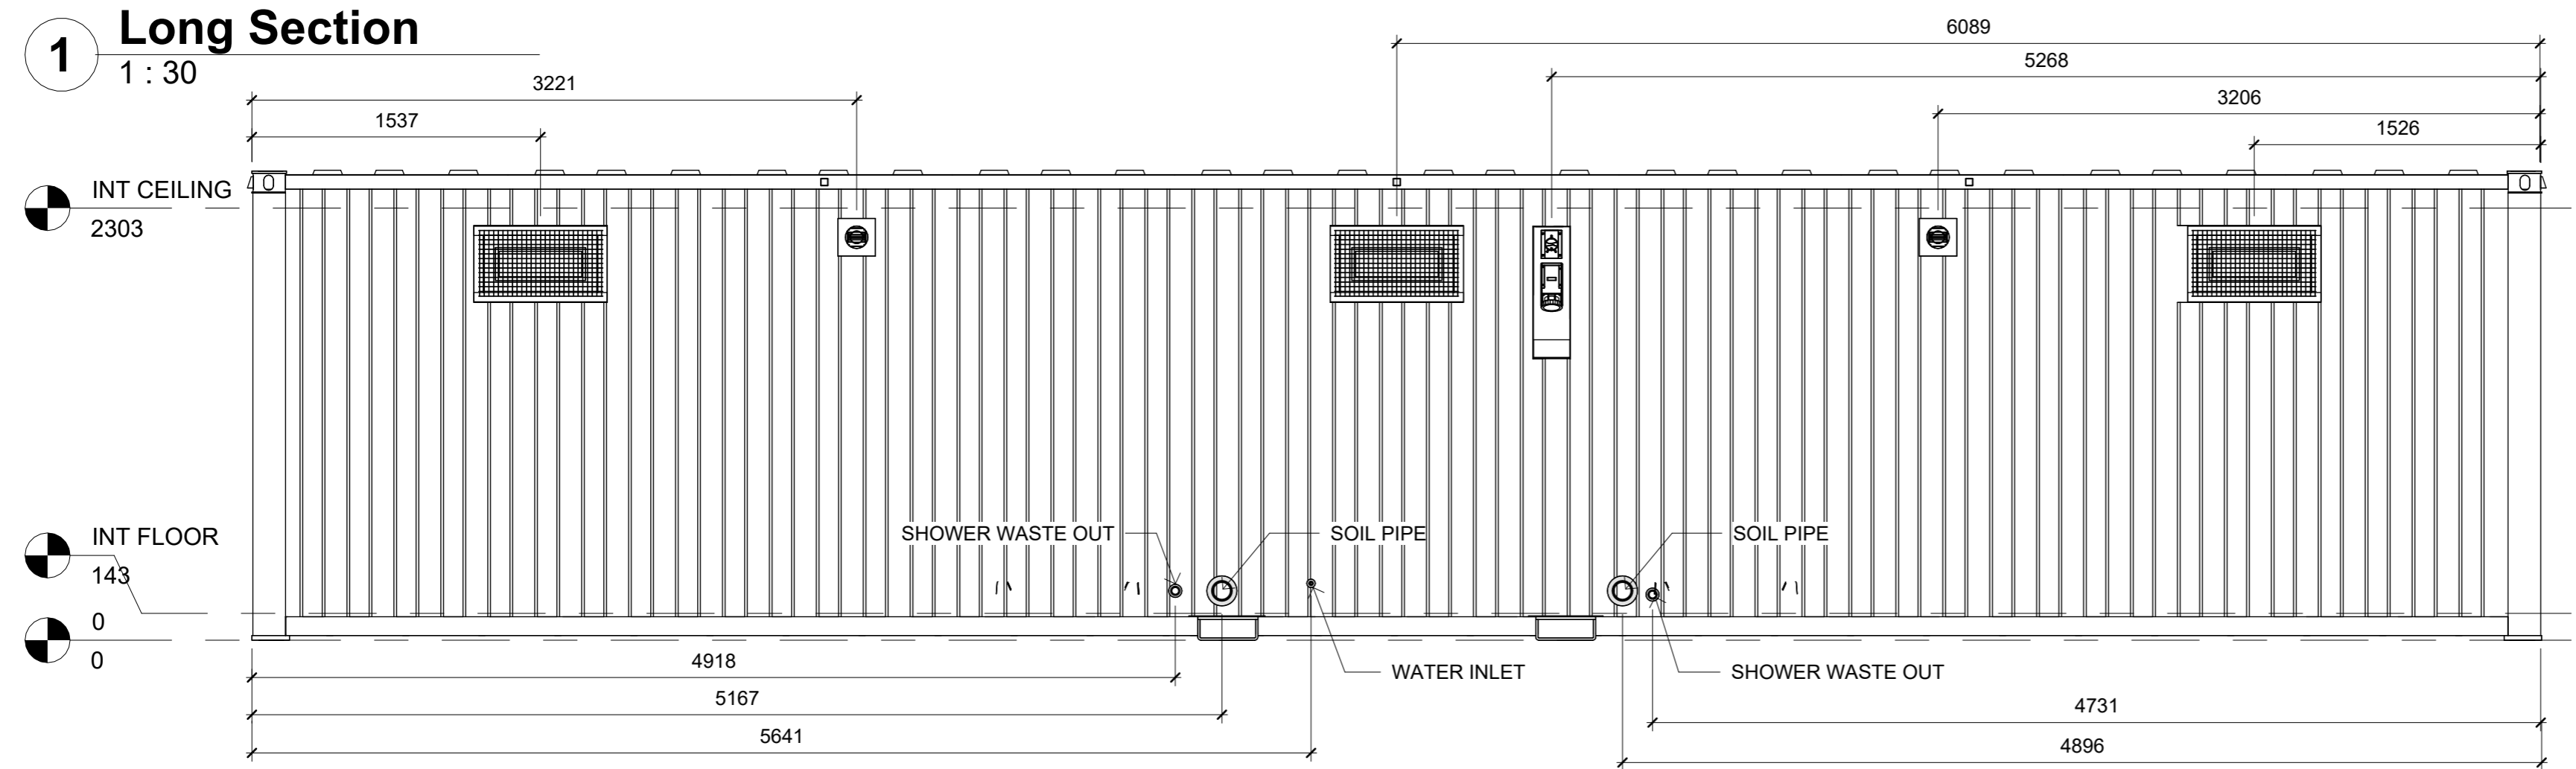

**4 Rear Elevation**  
1 : 30

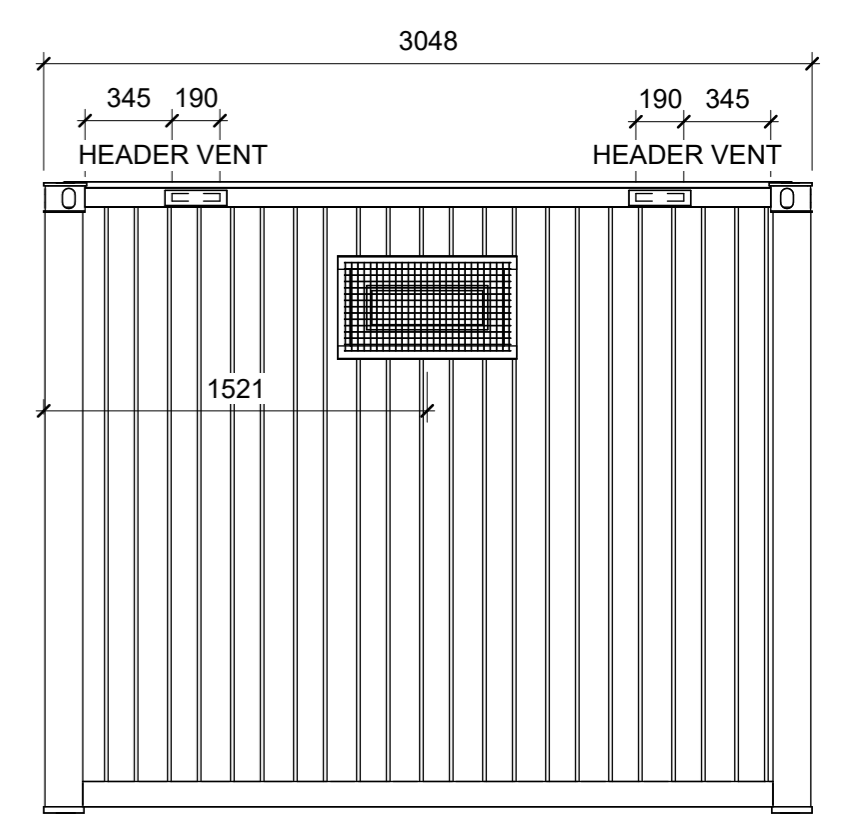


**3 End Elevation**  
1 : 30

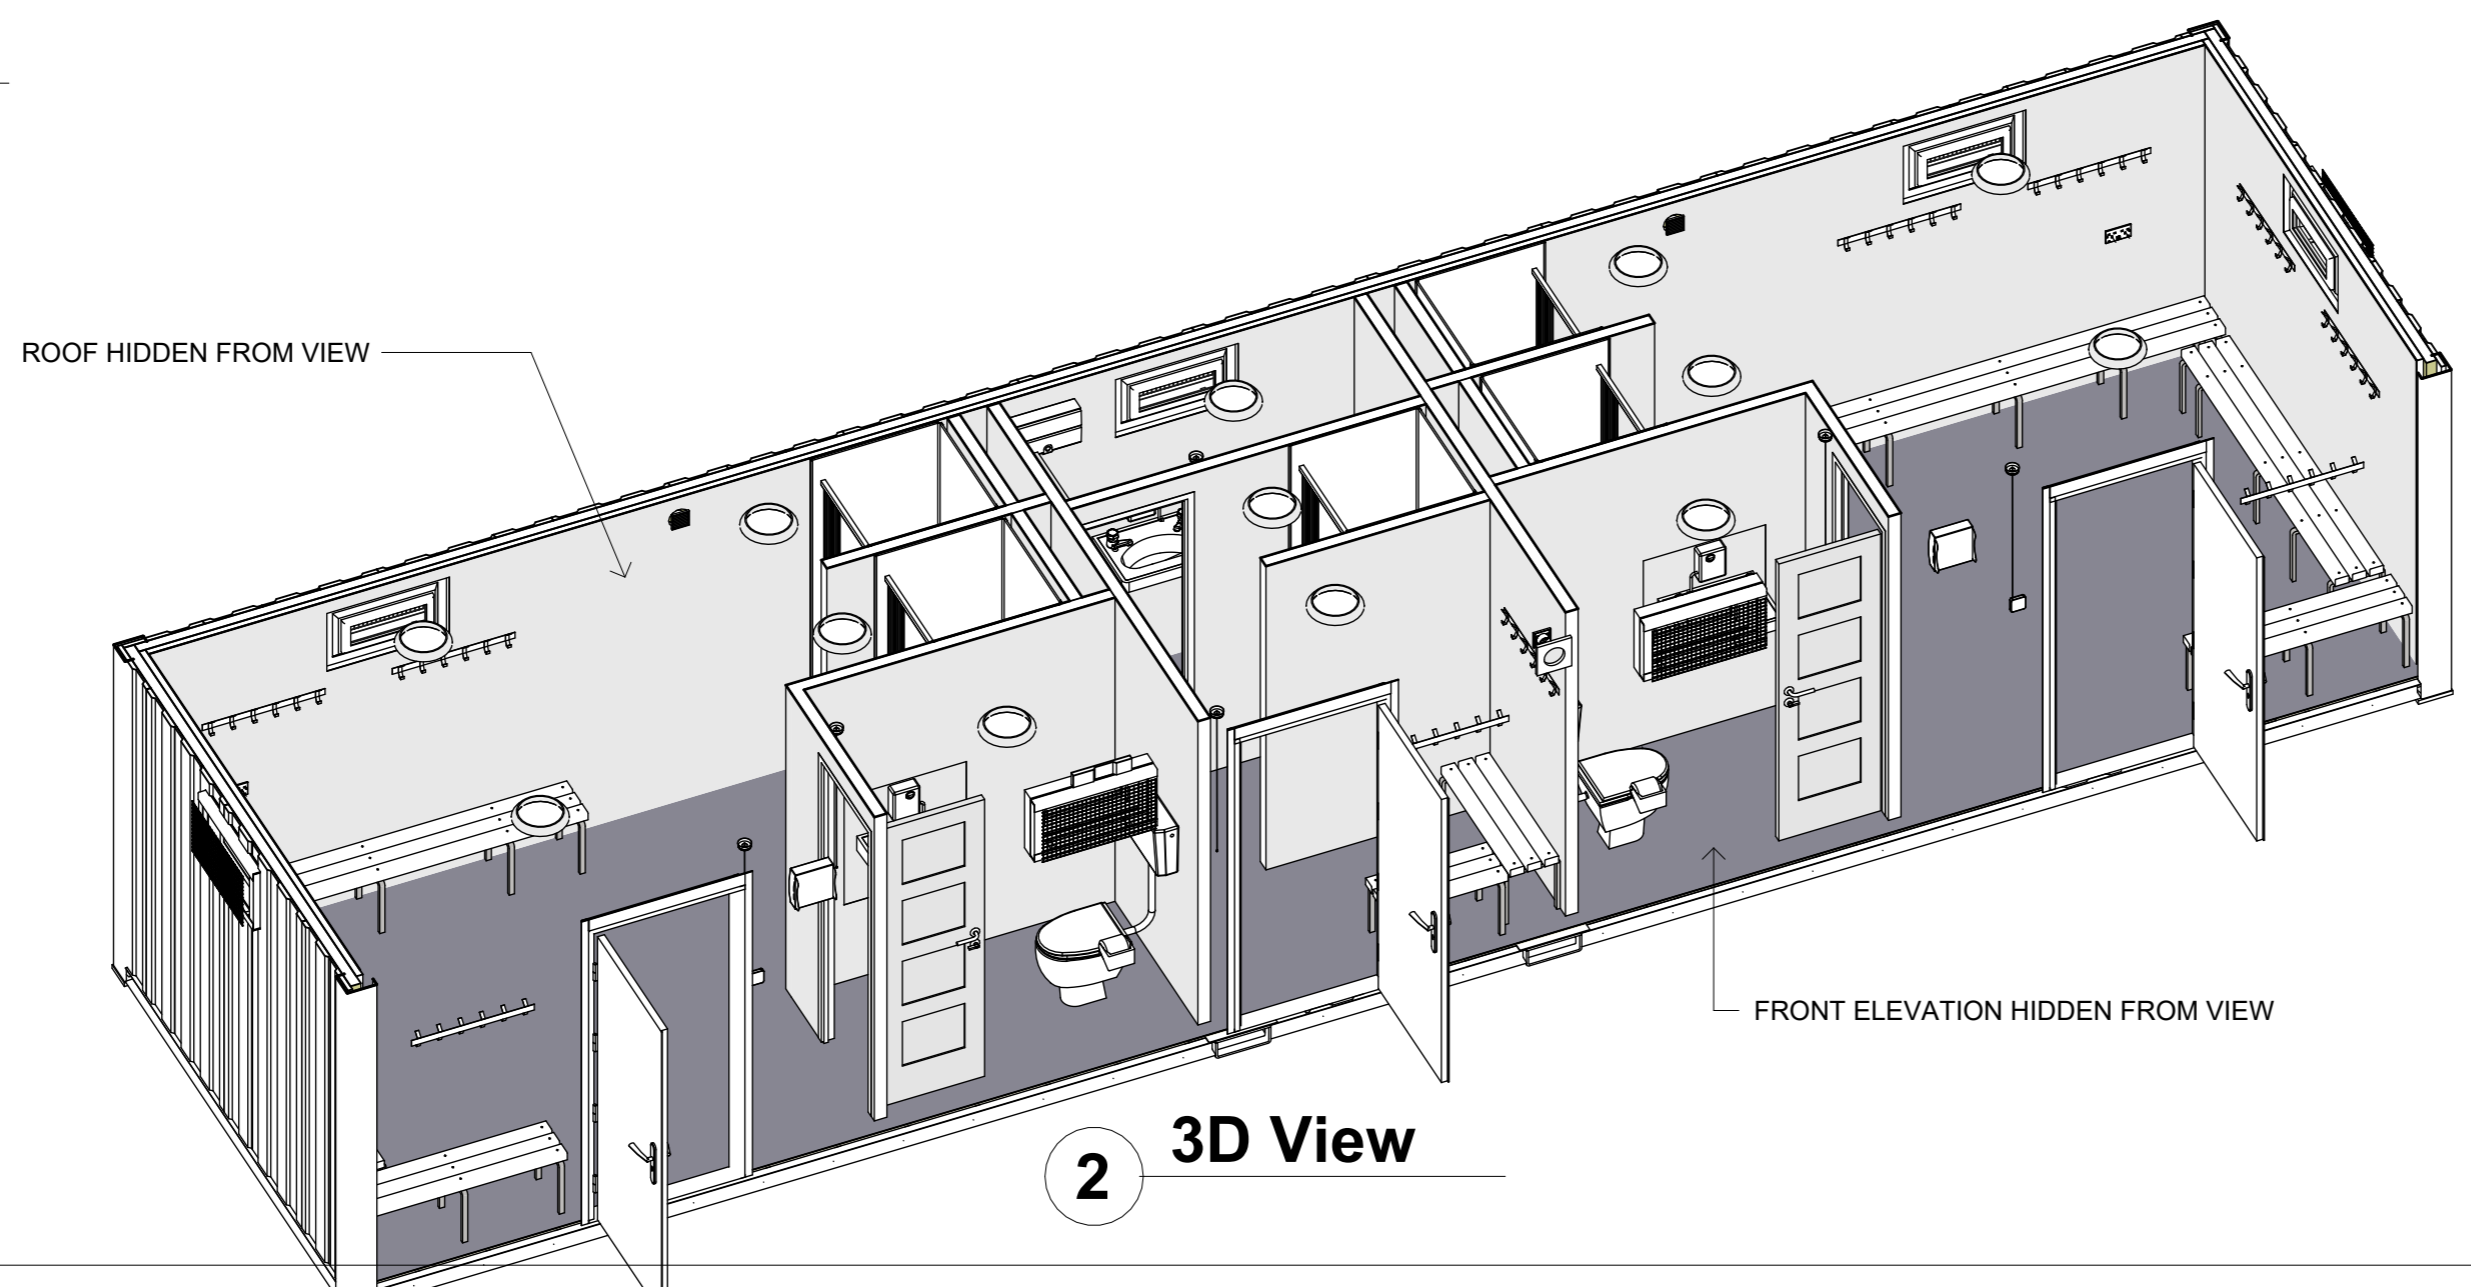

**2 3D View**

<b>MAC</b> CONTAINERS	
CLIENT: Mac Containers	
PROJECT NO: NS00014-MAC-TO-4010	
DRAWING NAME: Overall Layout 2	
DRAWING NUMBER: 02	
REV: B	REV DATE: 06/07/23
REV DESCRIPTION: VOID ADDED FOR PIPEWORK	
DRAWN BY: MB	CHECKED BY: JH
DRAWING STATUS: FOR PRODUCTION	
SCALE:	1 : 30

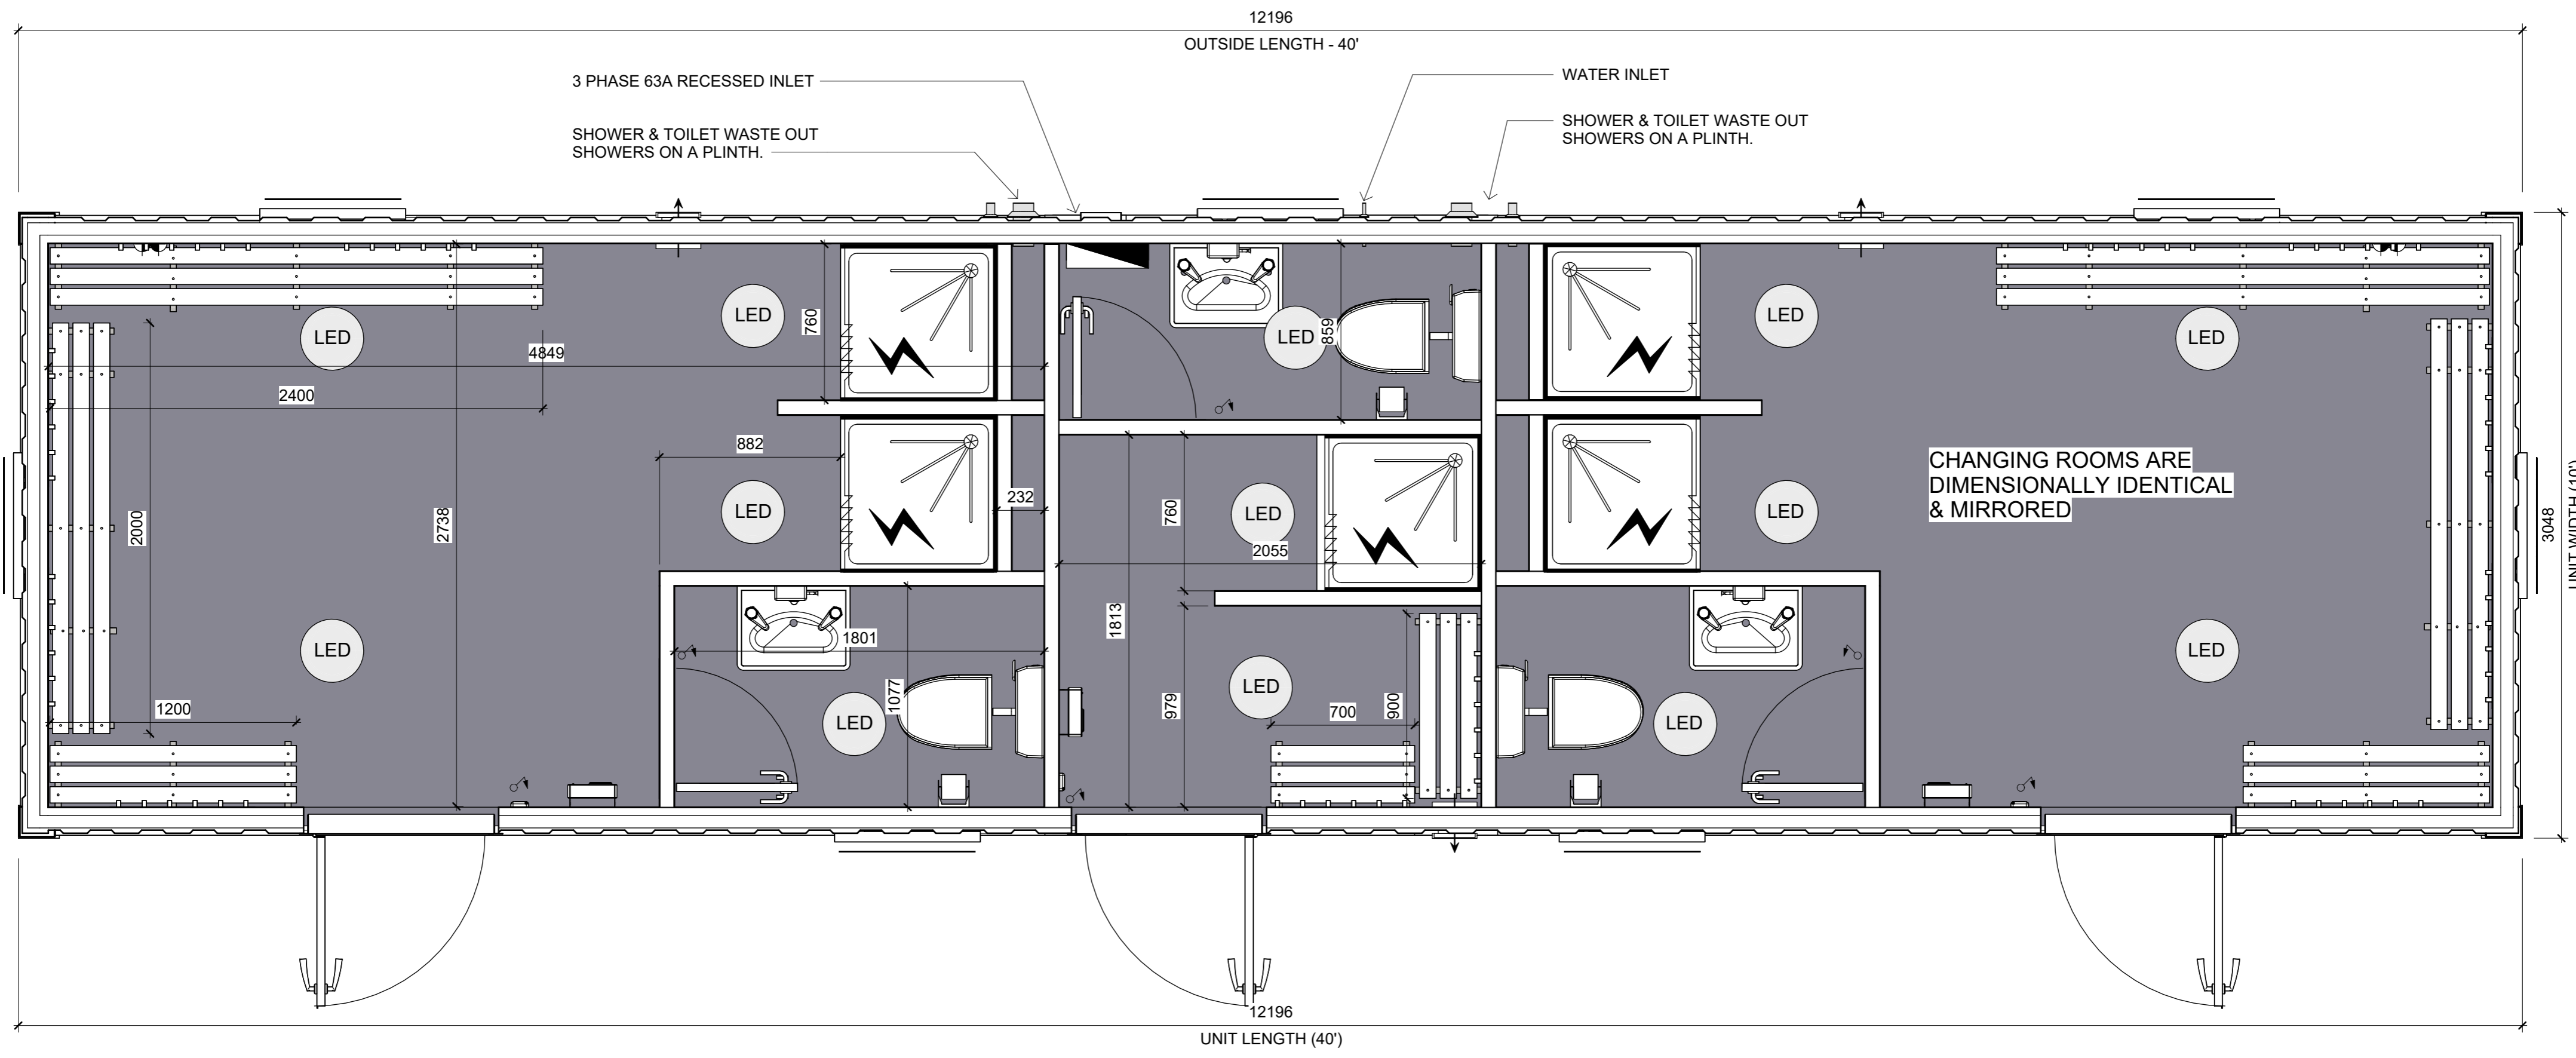

**1** Plan View Lining  
1 : 22

DRAWING NAME: PLAN VIEW	
DRAWING NUMBER: 03	
REV: B	REV DATE: 06/07/23
REV DESCRIPTION: VOID ADDED FOR PIPEWORK	
DRAWN BY: MB	CHECKED BY: RA
DRAWING STATUS: FOR PRODUCTION	
SCALE:	1 : 22